



ROUTE 22

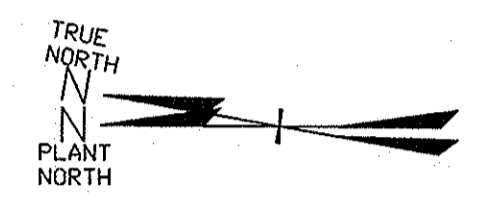

FG METERING STATION

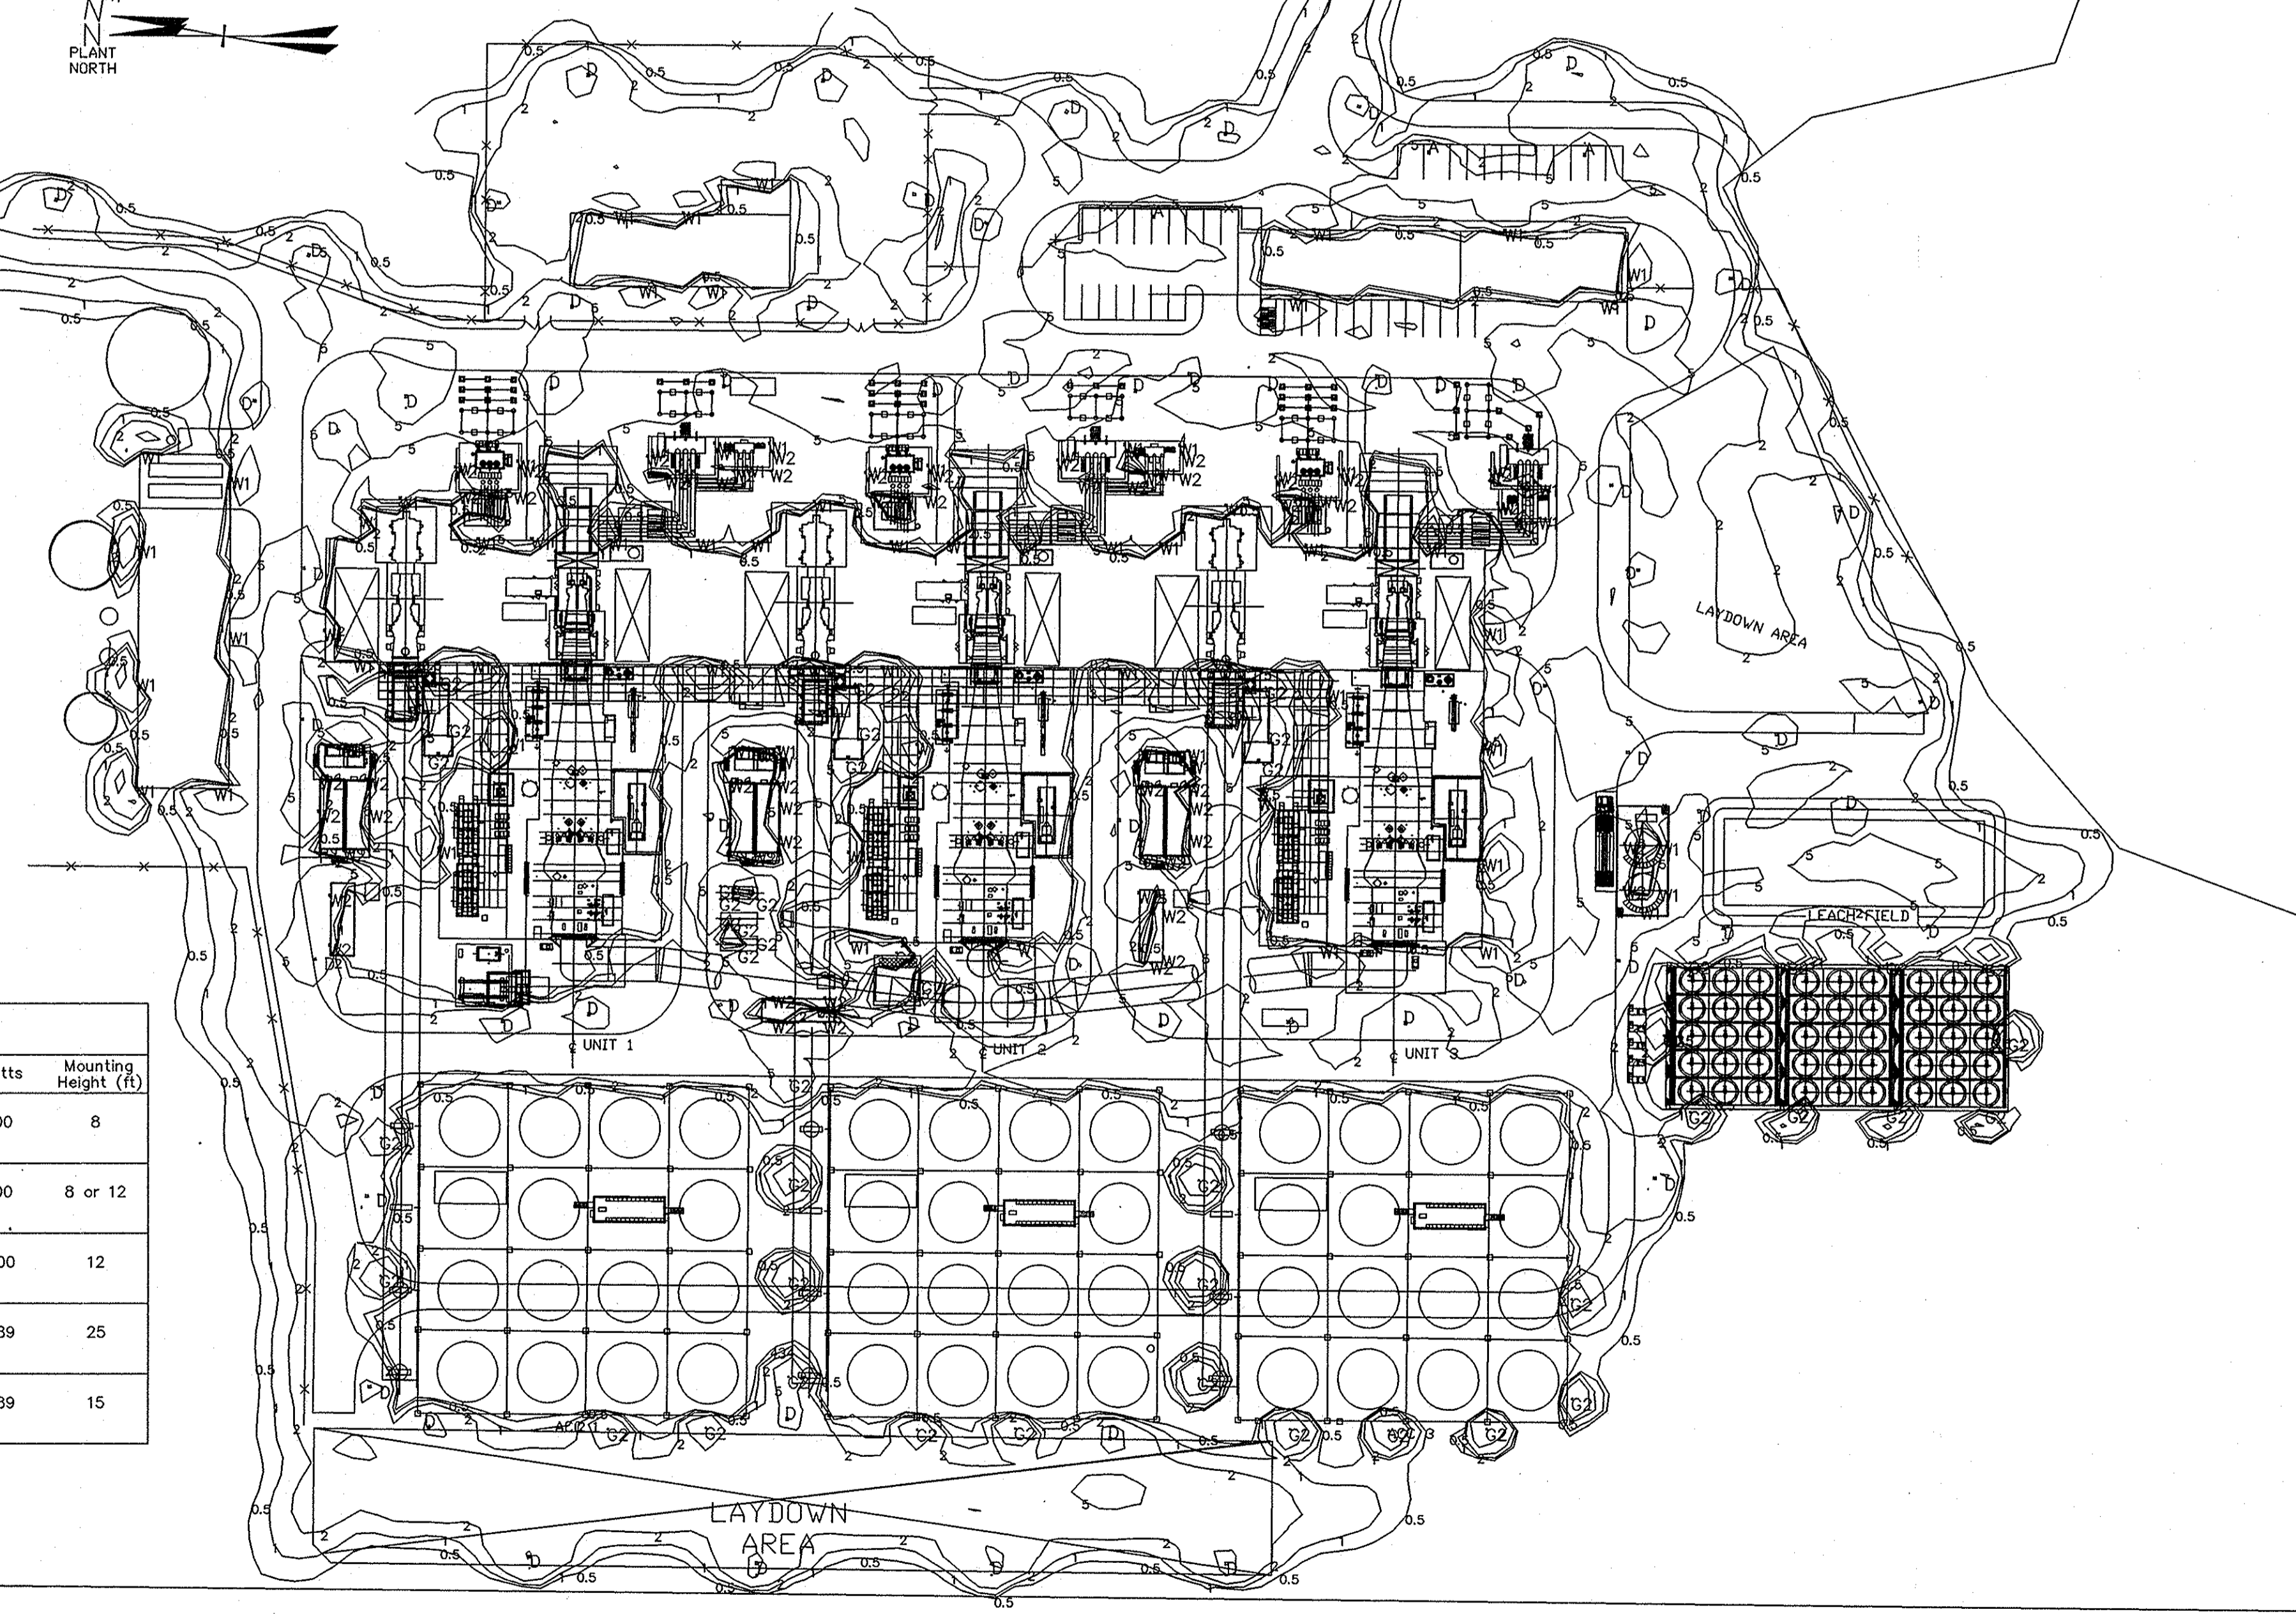

PROPERTY LINE

**NOTES**  
1. Locations of fixture types stated under Luminaire Schedule are shown on this drawing.

LUMINAIRE SCHEDULE									
Label	Qty	Catalog Number	Description	Lamp	File	Lumens	LLF	Watts	Mounting Height (ft)
G2	46	H2210S5SGGQ	FILTER-GARD H2	1; 100W HPS, CLEAR ED23.5, VBU	GE177024.IES	9500	0.86	100	8
W1	91	W25C10S2M1GM GLDB	WALLLIGHTER 250 CUTOFF	1; 100W HPS, CLEAR ED23.5, VBU	GE178825.IES	9500	0.86	100	8 or 12
W2	54	W25C20S2M1GM GLDB	WALLLIGHTER 250 CUTOFF	1; 200W HPS, CLEAR ED18, HORZ	GE178830.IES	22000	0.86	200	12
D	73	G250HP00HDCXXX	MONGOOSE	250W CLEAR HPS	G250HP00HD CXXX.ies	28000	1.00	289	25
A	3	G250HP00HDCXXX	MONGOOSE	250W CLEAR HPS	G250HP00HD CXXX.ies	28000	1.00	289	15

ALL EXTERIOR LIGHTING

Rev No	Revision	Date	Dwn	Chkd	Approved Chief Engr	Rev No	Revision	Date	Dwn	Chkd	Approved Chief Engr	Rev No	Revision	Date	Dwn	Chkd	Approved Chief Engr	Drawing Control				Engineering Review					
A	ISSUED FOR COMMENT	7/9/10					B	ISSUED FOR PERMITTING	7/13/10										Purpose	Approved By	Date	Released By	Date	Disc	Engr	Date	
																			For Information	BSM	8/5/10	JM	8/10	Mech			
																			For Comment					Civil			
																			For Bid					Arch			
																			For Fabrication					Instr			
																			For Construction								


**advanced power** CRICKET VALLEY ENERGY TOWN OF DOVER DUTCHESS COUNTY, NEW YORK

**OUTDOOR LIGHTING PLAN WITH FULL LIGHTING LEVELS**

BURNS AND ROE ENTERPRISES, INC. Engineers and Constructors - Oradell, NJ New York Certificate of Authorization No. 0004677

Lead Engineer: R. SAINI Date: 7/21/10 Scale: NTS Approved for Construction: Chief ELECTRICAL Engineer Work Order: 3000 Drawing No: E600 Sh: B Rev: B

ROUTE 22

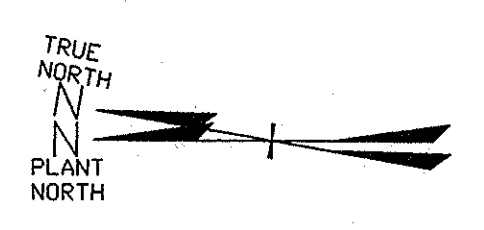

PG METERING STATION

LAYDOWN AREA

PROPERTY LINE

LEACH FIELD

LAYDOWN AREA

**NOTES**  
 1. Locations of fixture types stated under Luminaire Schedule are shown on this drawing.

Label	Qty	Catalog Number	Description	Lamp	File	Lumens	LLF	Watts	Mounting Height (ft)
G2	0	H2210SSGGQ	FILTER-GARD H2	1; 100W HPS, CLEAR ED23.5, VBU	GE177024.IES	9500	0.86	100	8
W1	79	W25C10S2M1GM GLDB	WALLLIGHTER 250 CUTOFF	1; 100W HPS, CLEAR ED23.5, VBU	GE178825.IES	9500	0.86	100	8 or 12
W2	27	W25C20S2M1GM GLDB	WALLLIGHTER 250 CUTOFF	1; 200W HPS, CLEAR ED18, HORZ	GE178830.IES	22000	0.86	200	12
D	53	G250HP00HDCXXX	MONGOOSE	250W CLEAR HPS	G250HP00HDCXXX.ies	28000	1.00	289	25
C	3	G250HP00HDCXXX	MONGOOSE	250W CLEAR HPS	G250HP00HDCXXX.ies	28000	1.00	289	15

\$\$\$\$TIME\$\$\$  
\$\$\$TIME\$\$\$  
\$\$\$TIME\$\$\$

Rev No	Revision	Date	Dwn	Chkd	Approved Chief Engr	Rev No	Revision	Date	Dwn	Chkd	Approved Chief Engr	Rev No	Revision	Date	Dwn	Chkd	Approved Chief Engr
A	ISSUED FOR PERMITTING													8/10	TR		Raman

Drawing Control				
Purpose	Approved By	Date	Released By	Date
For Information	Raman	8/10	Dum	8/10
For Comment				
For Bid				
For Fabrication				
For Construction				

Engineering Review		
Disc	Engr	Date
Mech		
Elec		
Civil		
Arch		
Instr		
Drawn	Designed	Checked
Lead Engineer	Date	Approved for Construction
R. SAINI	7/29/18	Chief ELECTRICAL Engineer

**advanced power** CRICKET VALLEY ENERGY  
 TOWN OF DOVER  
 DUTCHESS COUNTY, NEW YORK

OUTDOOR LIGHTING PLAN WITH REDUCED LIGHTING LEVELS DURING NORMAL PLANT OPERATION

**BURNS AND ROE ENTERPRISES, INC.**  
 Engineers and Constructors - Oradell, NJ  
 New York Certificate of Authorization No. 0004677

Approved for Construction Work Order Drawing No Sh Rev  
 Chief ELECTRICAL Engineer 3000 E601 A